


LIGHTING FIXTURE SCHEDULE									
TAG	DESCRIPTION	LUMINOUS FLUX	COLOR TEMPERATURE (KELVIN)	MOUNTING	MANUFACTURER	MODEL	VOLT	WATT	QTY
L-1	LED 2X2	4000 lm	5000K	SURFACE OR SUSPENDED	BRILLIRARE	B09K73P1CZ	120	40	26
L-2	LED 4X4	6000 lm	3500K-5000K	SURFACE OR SUSPENDED	LITHONIA LIGHTING	B09KBQDLDV	120	55	42
EL-1	INTERNAL EMERGENCY LIGHT	90 lm	5000K-9000K	WALL	LITHONIA LIGHTING	B07KJDBVC6	120	2	19
EL-2	EXTERNAL LED SUSPENDED EMERGENCY LIGHT	220 lm	5000K	SUSPENDED	LIGHT FIXTURE INDUSTRIES	B07WFWH9RL	120	3	3
EL-3	LED EMERGENCY EXIT SIGN			WALL	ERALUX	CR-7037R	120	5	8

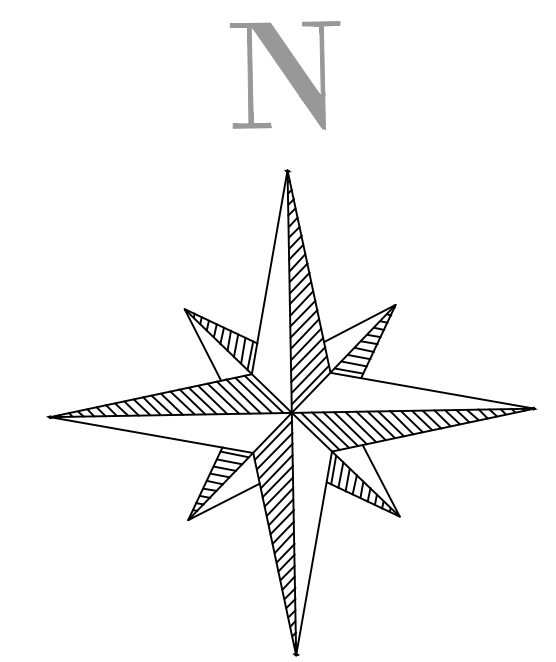

EMERGENCY LIGHTS LEGEND	
	EXIT SIGN
	ARROWS & EXIT FACE
	INTERNAL EMERGENCY LIGHTING UNIT WITH LIGHT HEADS
	EXTERNAL SUSPENDED EMERGENCY LIGHTING UNIT

ELECTRICAL RACEWAYS LEGEND	
	EMERGENCY LIGHTS RACEWAY SYSTEM

PROGRESS SET
FOR REVIEW ONLY

ISSUED 12/02/26

THESE DOCUMENTS ARE FOR DESIGN REVIEW AND NOT INTENDED FOR CONSTRUCTION, BIDDING OR PERMIT PURPOSES. THEY WERE PREPARED BY OR UNDER THE SUPERVISION OF:

JUAN A. MURILLO
TEXAS PE #94313

NO	DESCRIPTION	DATE
LOG OF SUBMISSION /REVISION		
 Engineering & Construction Integration Services, Inc. www.ecis-engineering.com TBPE Firm Registration No. F-20414 1303 W. WALNUT HILL LANE, SUITE 285 IRVING, TEXAS 75038 214-591-3100		
SHEET EMERGENCY LIGHTING PLAN		
OWNER	AMMAR SHOMALI	ENGINEER
ADDRESS	1245 LONGHORN ROAD CITY OF FORT WORTH TEXAS 76179	JUAN A. MURILLO 1303 W. WALNUT HILL LN. SUITE 285 IRVING, TEXAS 75038 214-591-3100 MAIL ADDRESS jmurillo@ecis-engineering.com
PROJECT		
VICTORY HUB GAS STATION		
DESIGNED	VERENA ANTEZANA	CHECKED
DRAWN	VERENA ANTEZANA	APPROVED
		JUAN A. MURILLO
SUB	LOT	BLK
LONGHORN PLAZA ADDITION	01	A
SUBMISSION DATE		08/18/2023
FILE NUMBER		2224.1245
SHEET NO		E1.03

1 EMERGENCY LIGHTING PLAN
E1.03 SCALE: 1/4" = 1'