


1 MECHANICAL PLAN
M1.00 SCALE: 1/4" = 1'

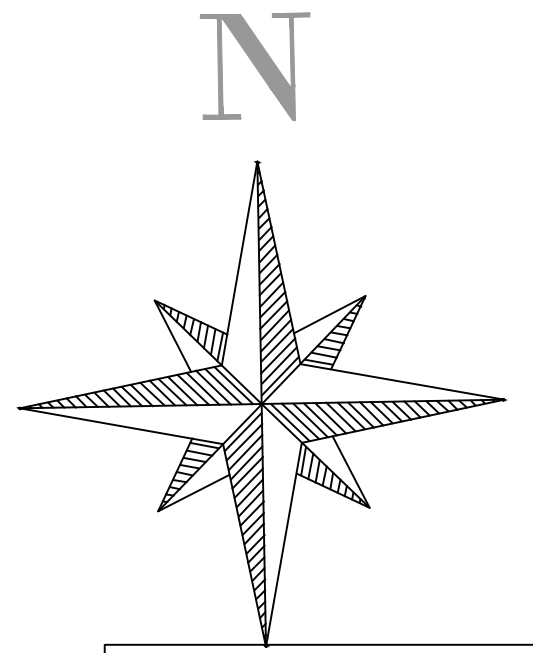


HVAC LEGEND	
	ROOF TOP UNIT
	CONDENSER
	MONOBLOCK REFRIGERATION UNIT
	AIR SUPPLY DIFFUSER (CEILING)
	AIR RETURN GRILLE (CEILING)
	DIRECTION OF AIR
	SUPPLY DUCT
	RETURN DUCT
	REFRIGERANT LINESET
	GAS LINE

**PROGRESS SET
FOR REVIEW ONLY**

ISSUED 12/02/26

THESE DOCUMENTS ARE FOR DESIGN REVIEW AND NOT INTENDED FOR CONSTRUCTION, BIDDING OR PERMIT PURPOSES. THEY WERE PREPARED BY OR UNDER THE SUPERVISION OF:

JUAN A MURILLO
TEXAS PE #94313

NO	DESCRIPTION	DATE
LOG OF SUBMISSION /REVISION		
 Engineering & Construction Integration Services, Inc. www.ecis-engineering.com TBPE Firm Registration No. F-20414 1303 W. Walnut Hill Lane, Suite 285 Irving, Texas 75038 214-591-3100		
SHEET MECHANICAL PLAN		
OWNER	AMMAR SHOMALI	ENGINEER
ADDRESS	1245 LONGHORN ROAD CITY OF FORT WORTH TEXAS 76179	JUAN A. MURILLO ADDRESS
		1303 W. WALNUT HILL LN. SUITE 285, IRVING, TEXAS 75038
		PHONE NUMBER
		214-591-3100
		MAIL ADDRESS
		jmurillo@ecis-engineering.com
PROJECT		
VICTORY HUB GAS STATION		
DESIGNED	VERENA ANTEZANA	CHECKED
DRAWN	VERENA ANTEZANA	JOSE G. MURILLO
		APPROVED
		JUAN A. MURILLO
SUB	LOT	BLK
LONGHORN PLAZA ADDITION	01	A
		SUBMISSION DATE
		08/18/2023
		FILE NUMBER
		2224.1245
		SHEET NO
		M1.00